


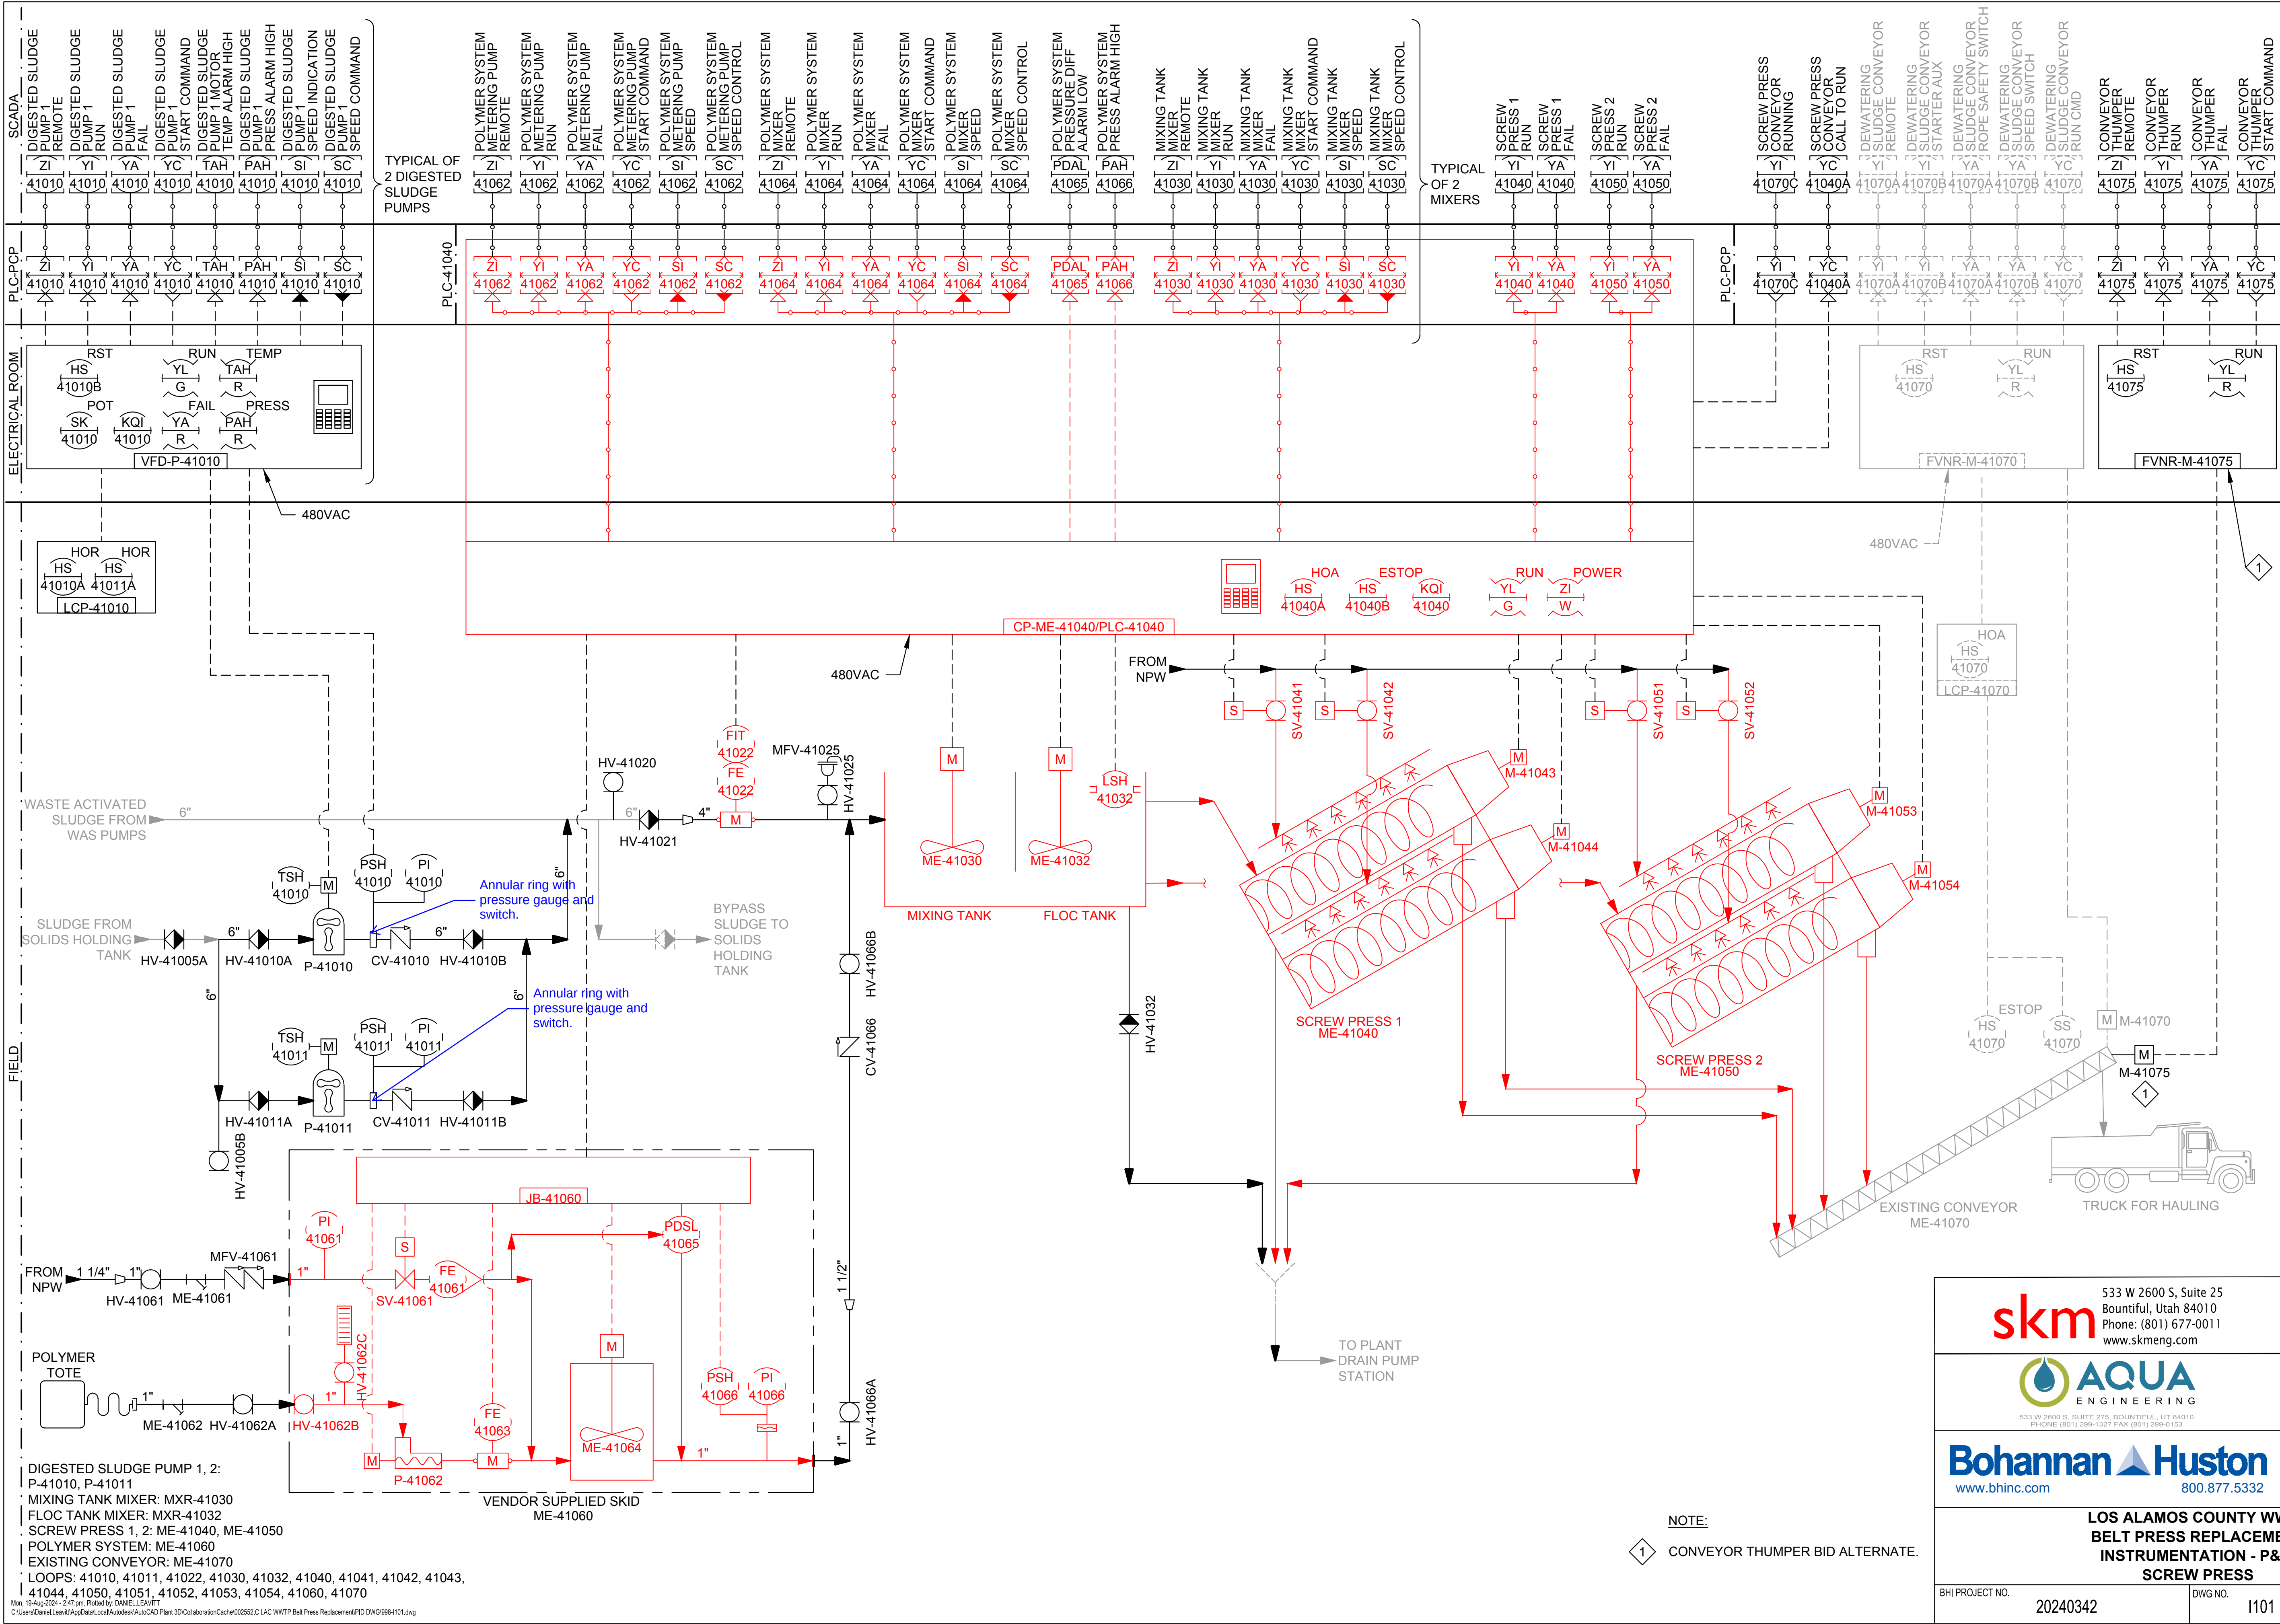

- DIGESTED SLUDGE PUMP 1, 2:
P-41010, P-41011
MIXING TANK MIXER: MXR-41030
FLOC TANK MIXER: MXR-41032
SCREW PRESS 1, 2: ME-41040, ME-41050
POLYMER SYSTEM: ME-41060
EXISTING CONVEYOR: ME-41070
LOOPS: 41010, 41011, 41022, 41030, 41032, 41040, 41041, 41042, 41043, 41044, 41050, 41051, 41052, 41053, 41054, 41060, 41070

Mon, 19-Aug-2024 - 2:47:00 PM. Plotted by: DANIEL LEAVITT
C:\Users\Daniel.Leavitt\AppData\Local\Autodesk\AutoCAD Plant 3D\Collaboration\Cache\02552C\LAC WWTP Belt Press Replacement\PD DWG\6984101.dwg

NOTE:
1 CONVEYOR THUMPER BID ALTERNATE.



Know what's below.
Call before you dig.

BENCH MARKS	



MARK P. JEPPESEN
NEW MEXICO
18018
09/09/2024
LICENSED PROFESSIONAL ENGINEER

AS-BUILT INFORMATION	
CONTRACTOR	DATE
WORK STARTED BY	DATE
INSPECTORS	DATE
ACCEPTANCE BY	DATE
FIELD VERIFICATION BY	DATE
DRAWINGS CORRECTED BY	DATE

REVISIONS	
BY	DATE

DESIGN	
DESIGNED BY	MPJ
CHECKED BY	MPJ
DRAWN BY	DCL



533 W 2600 S, Suite 25
Bountiful, Utah 84010
Phone: (801) 677-0011
www.skmeng.com



533 W 2600 S, SUITE 25, BOUNTIFUL, UT 84010
PHONE (801) 299-1327 FAX (801) 299-6123



www.bhinc.com 800.877.5332

LOS ALAMOS COUNTY WWTP
BELT PRESS REPLACEMENT
INSTRUMENTATION - P&ID
SCREW PRESS

BHI PROJECT NO.	DWG NO.	SHEET	OF
20240342	I101	45	56